

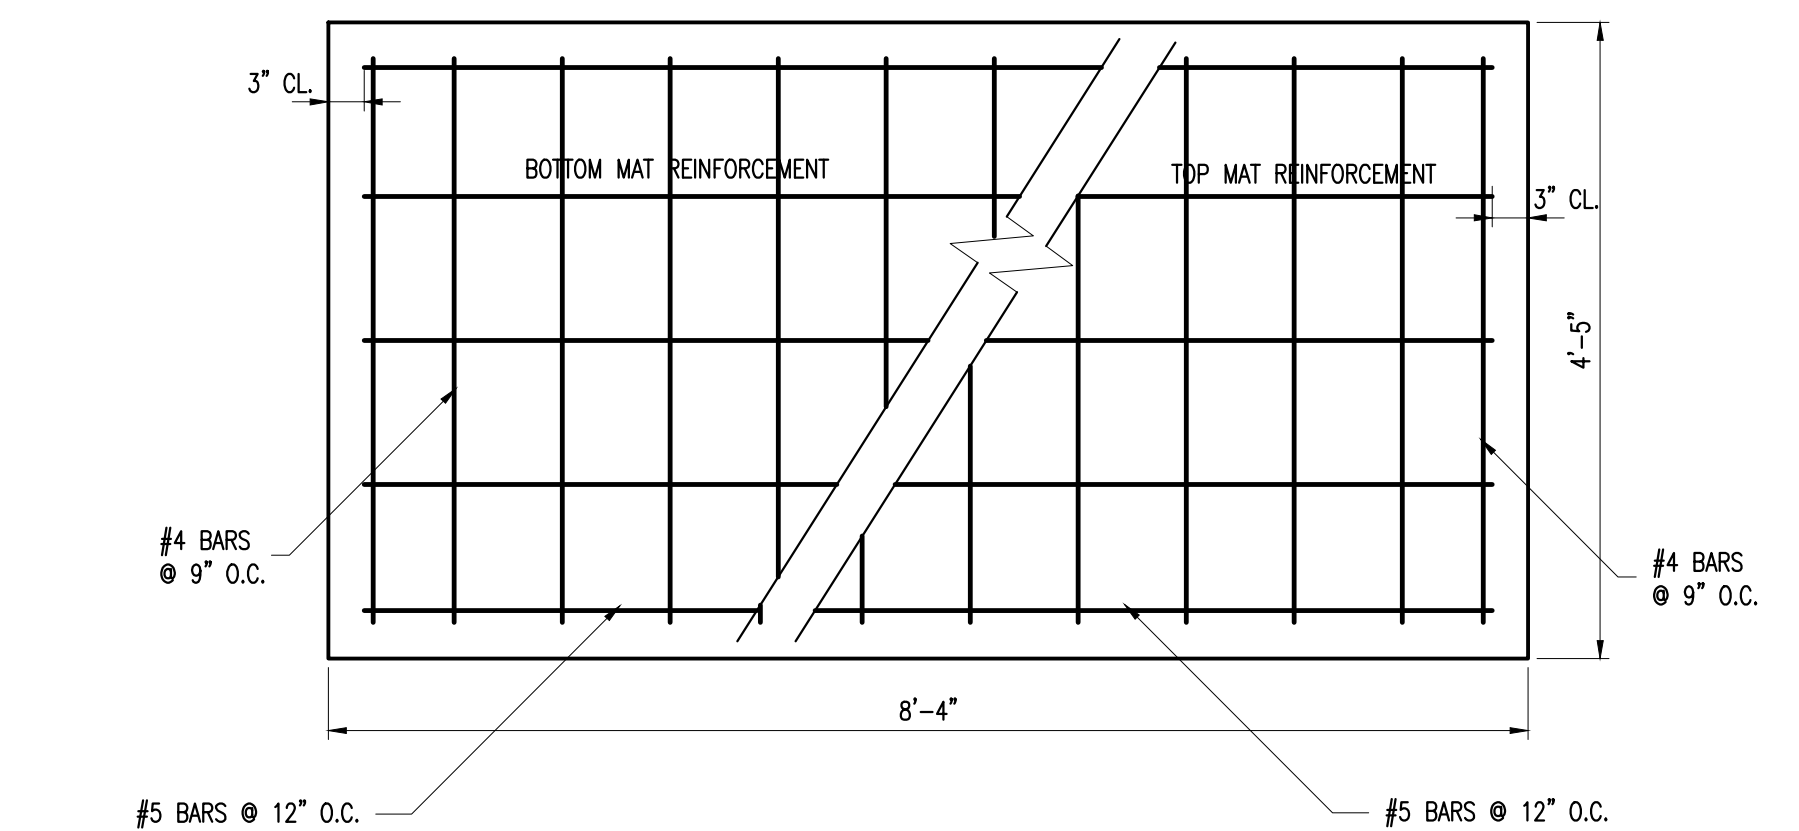
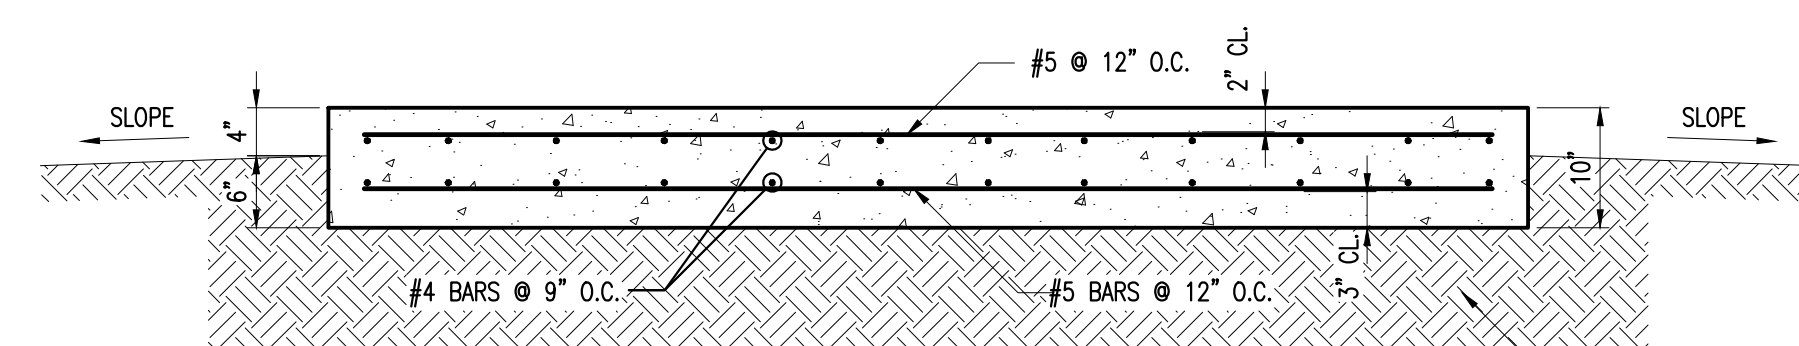
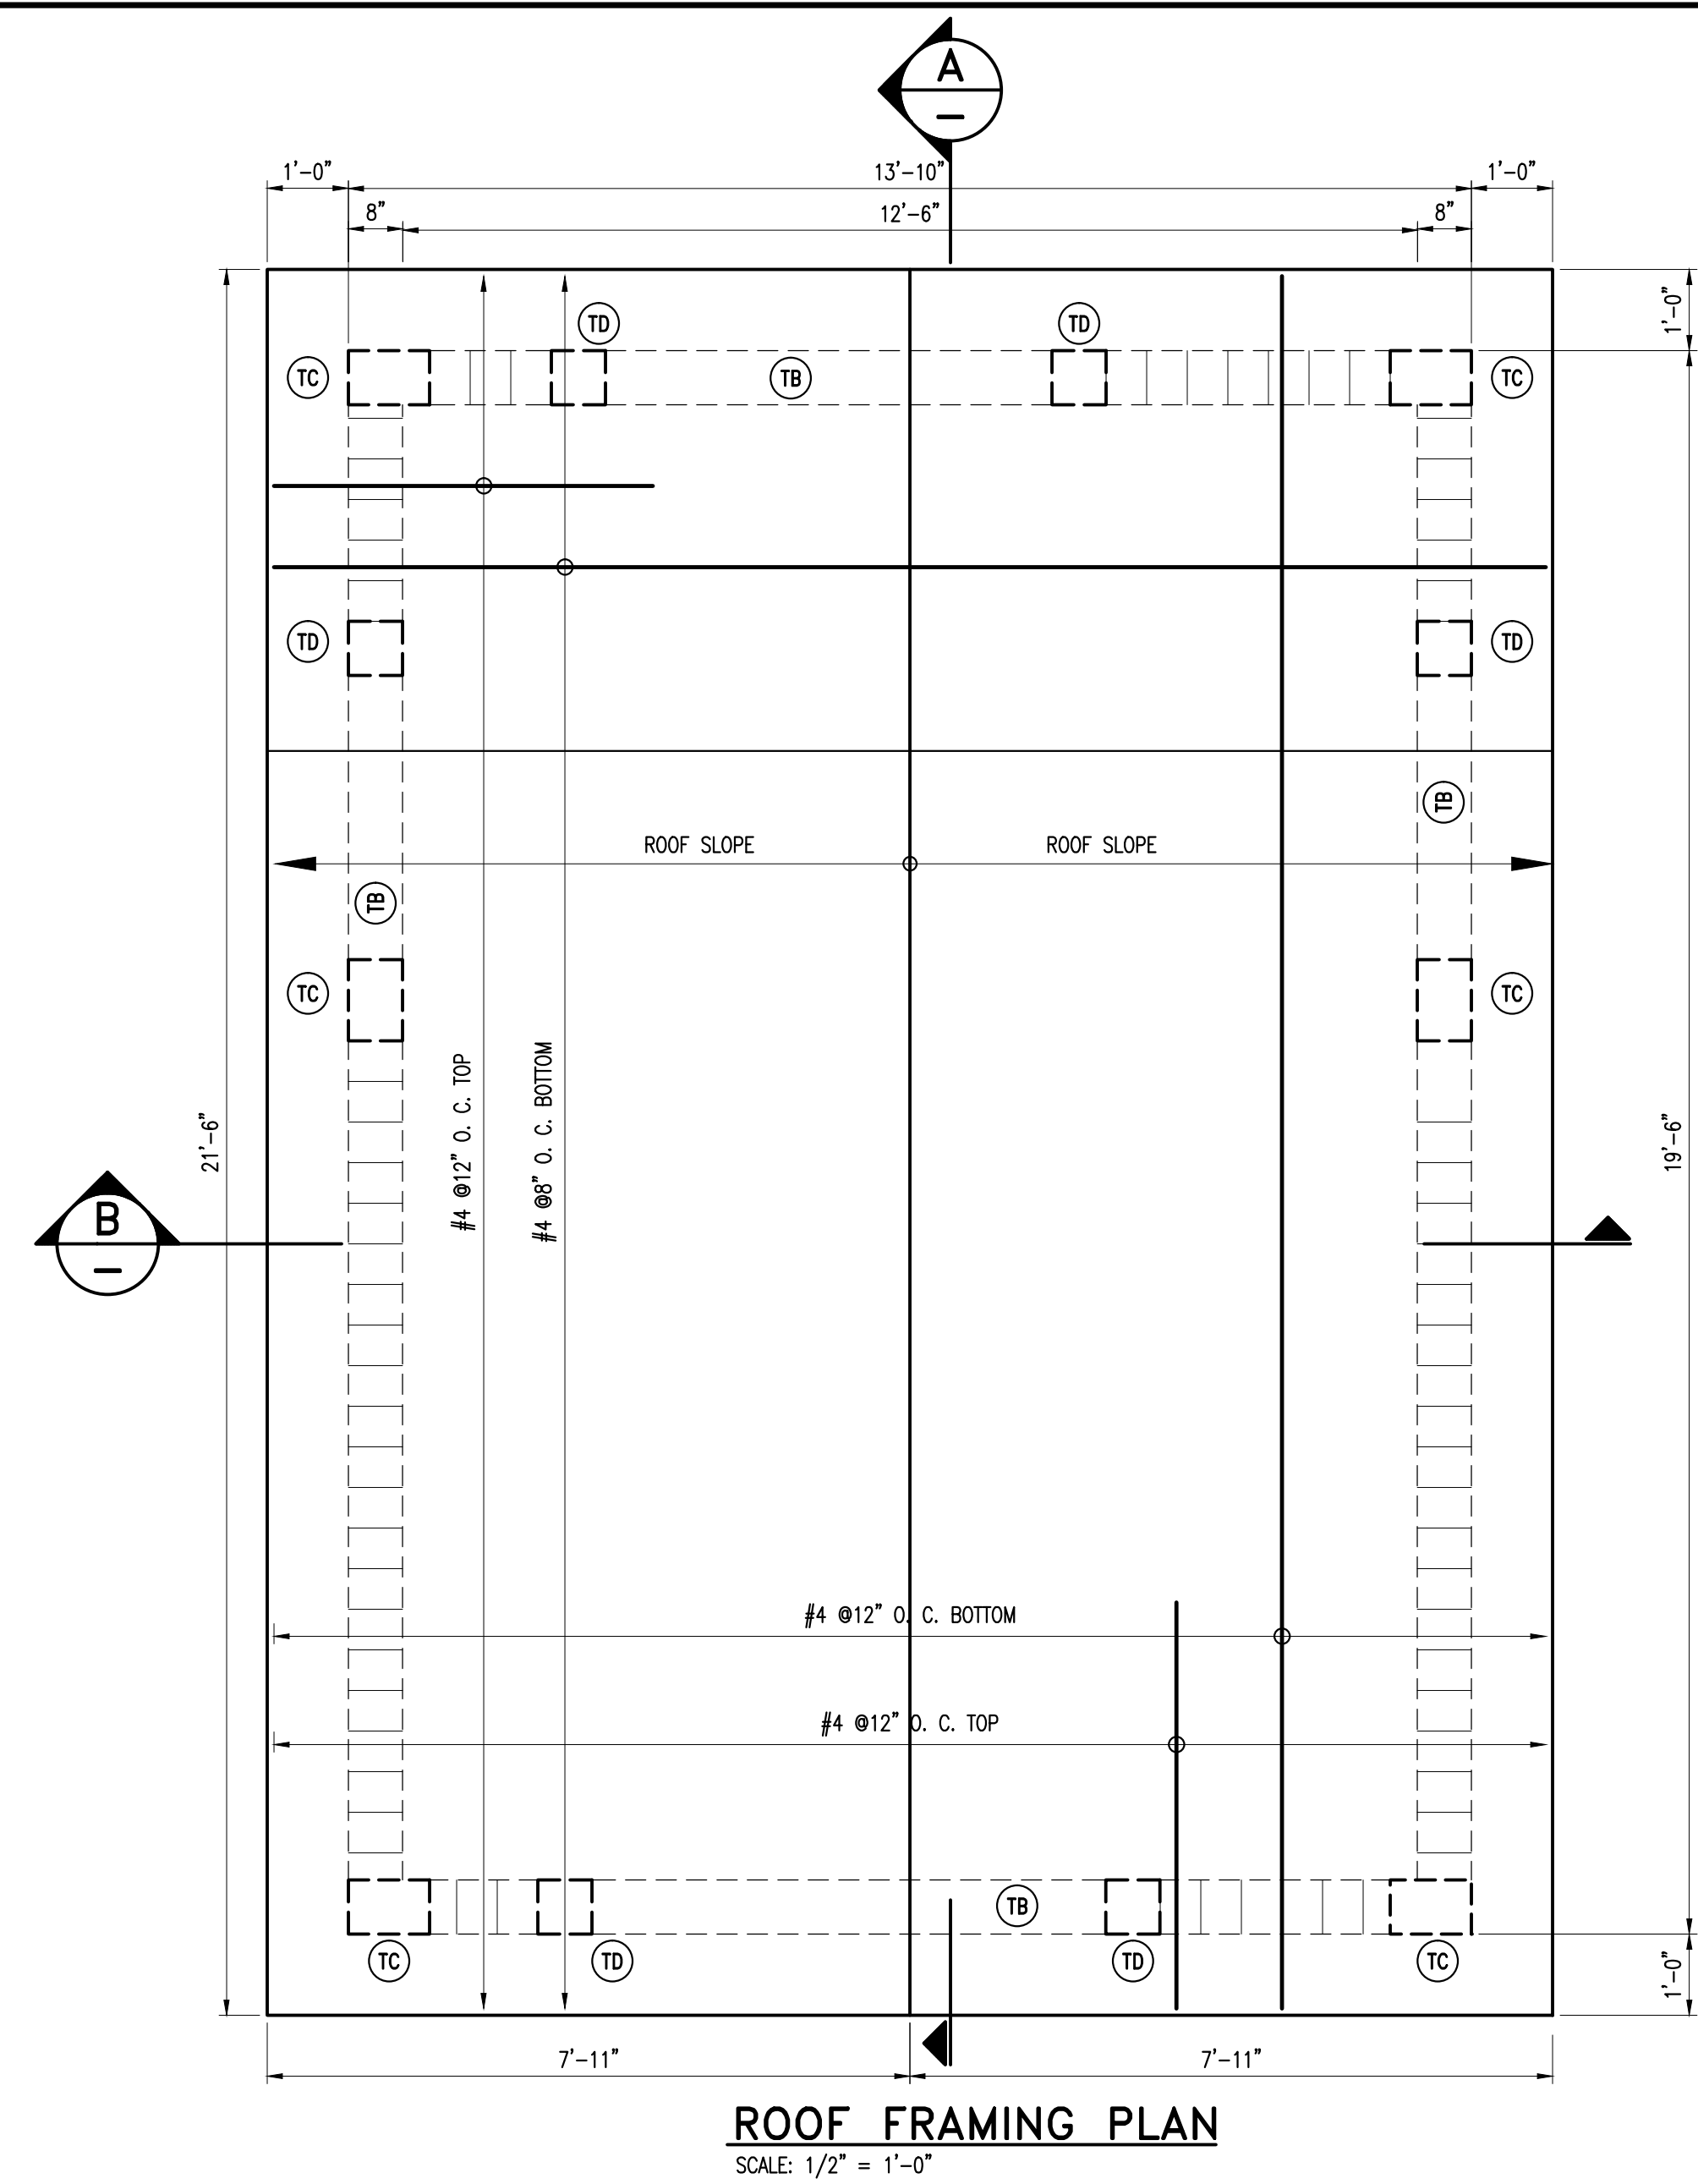
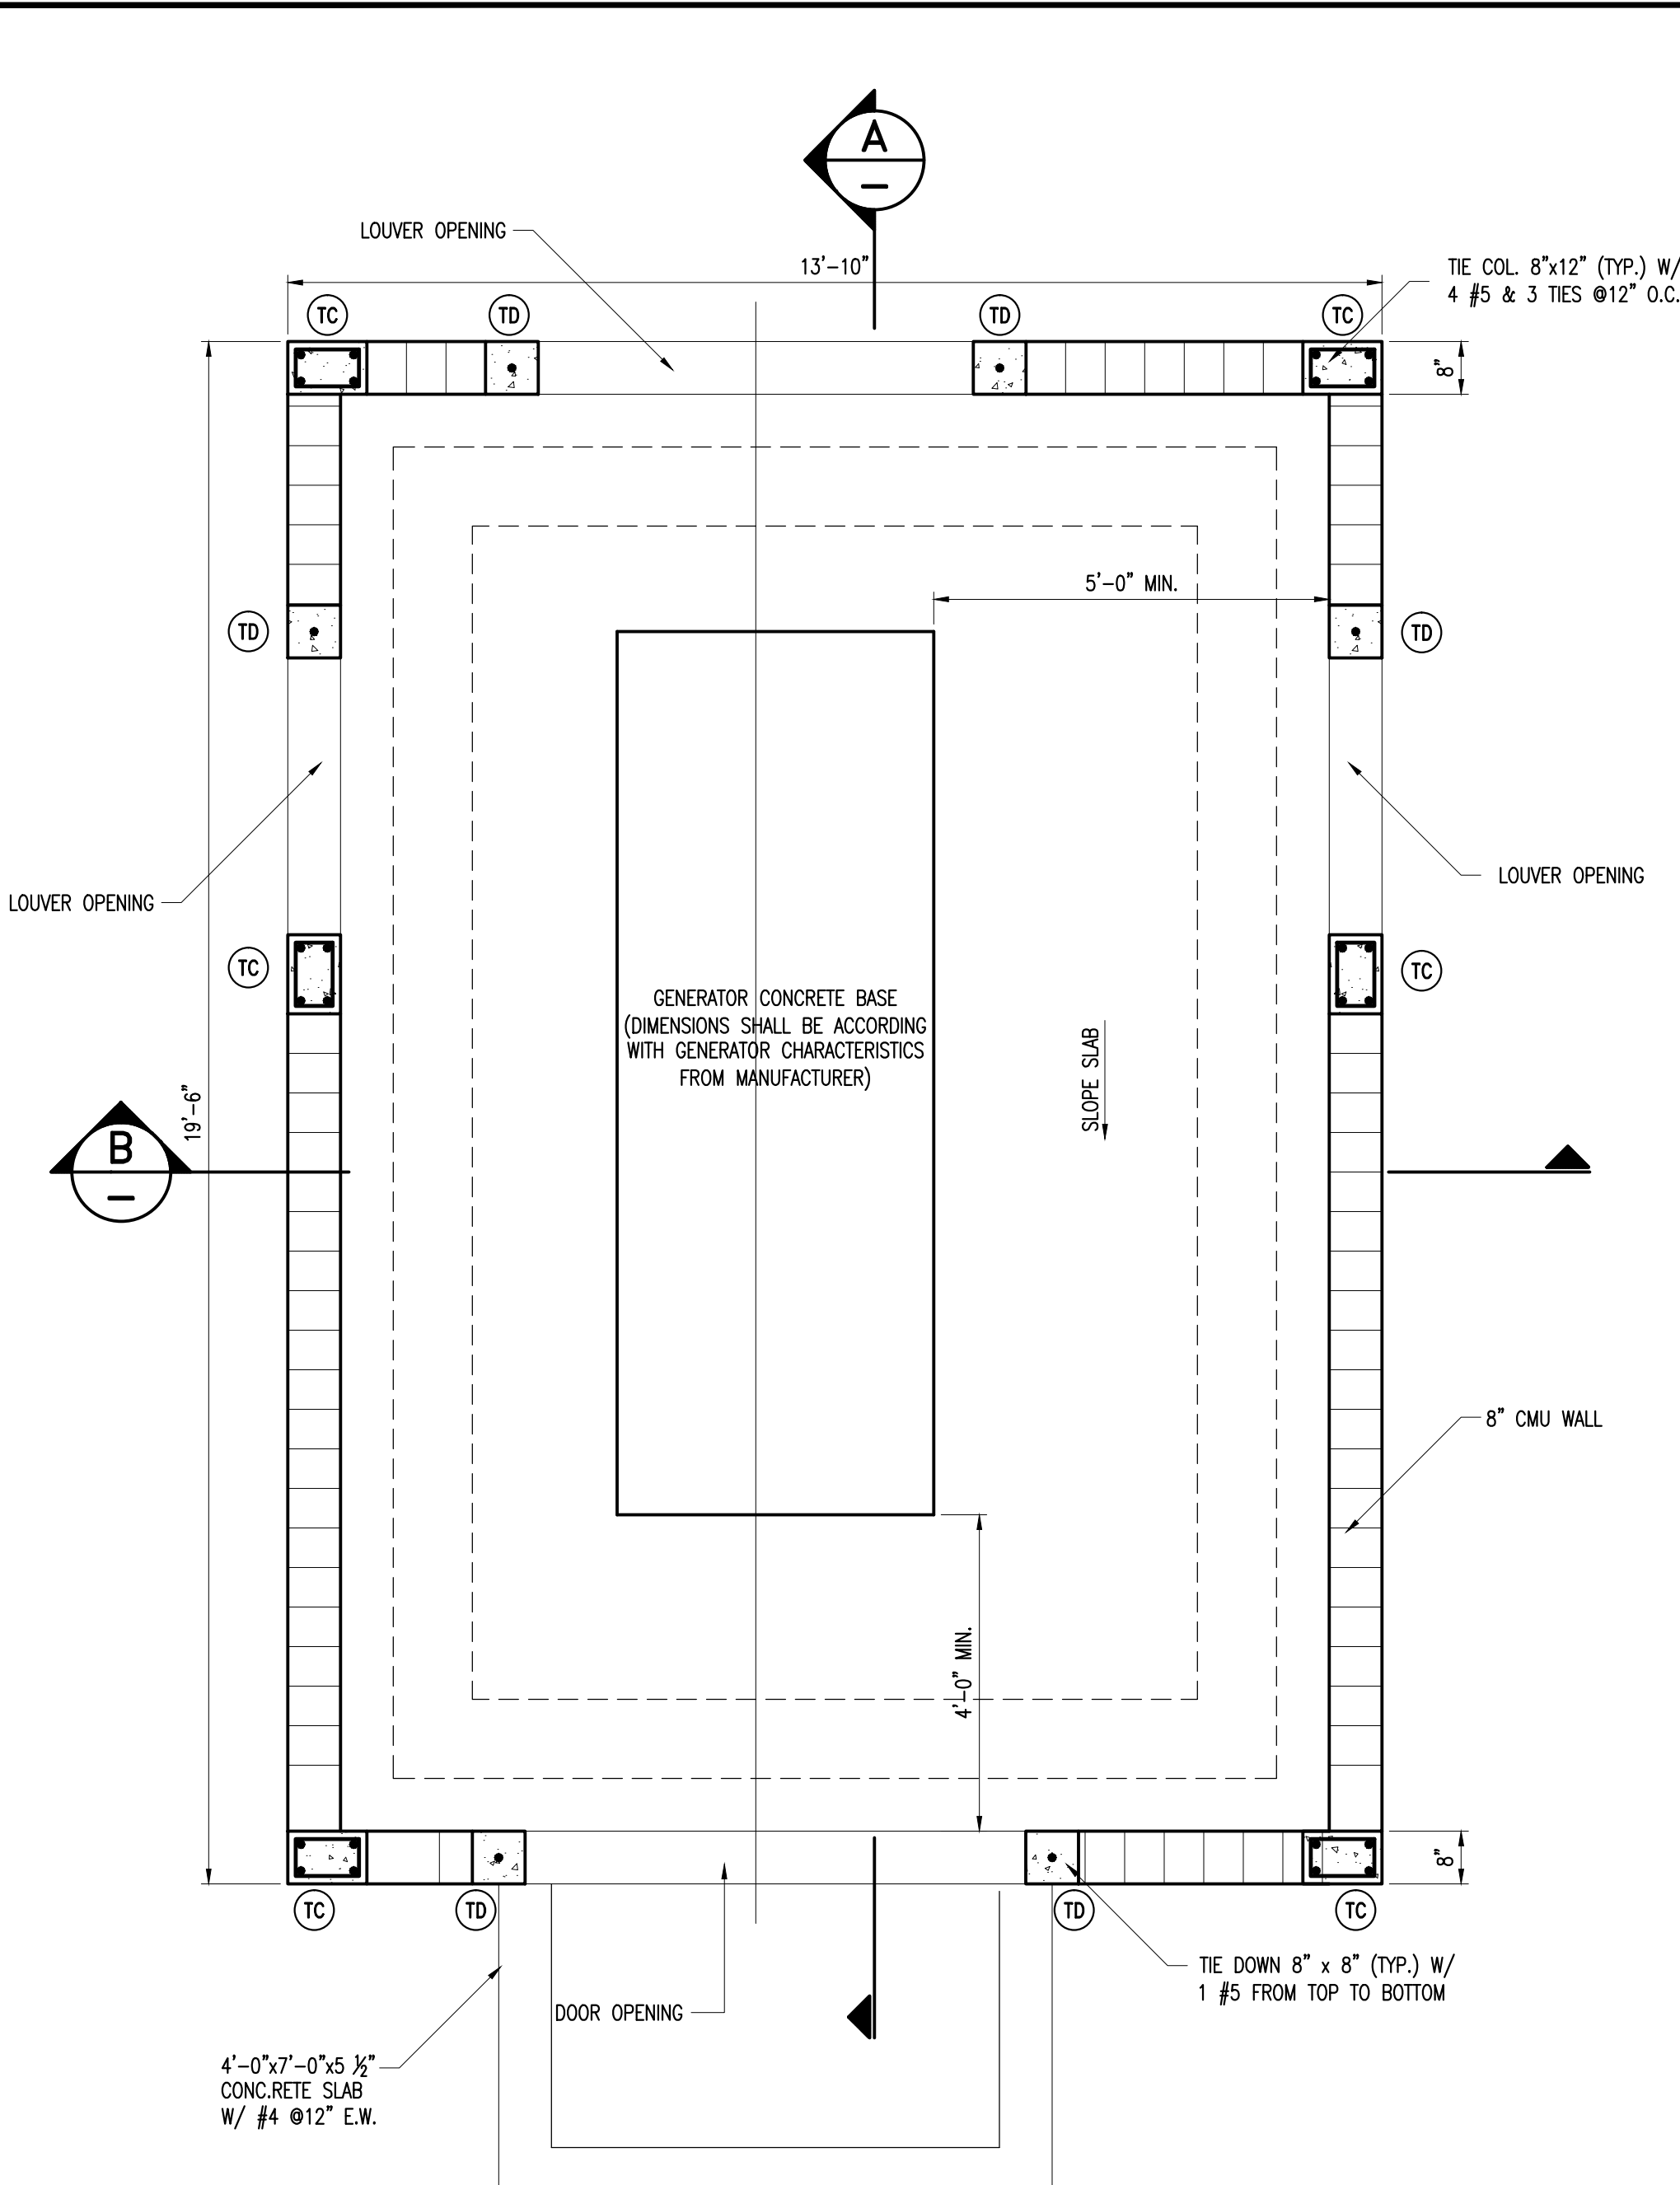


PUMP STATION No. 0000
FACILITY OFFICIAL ADDRESS, FLORIDA 33100-0000
DRY WELL/ WET WELL SEWAGE PUMP STATION
2012 WASH DESIGN STANDARD
EMERGENCY GENERATOR BUILDING
FOUNDATION PLAN, FLOOR PLAN, AND SECTIONS

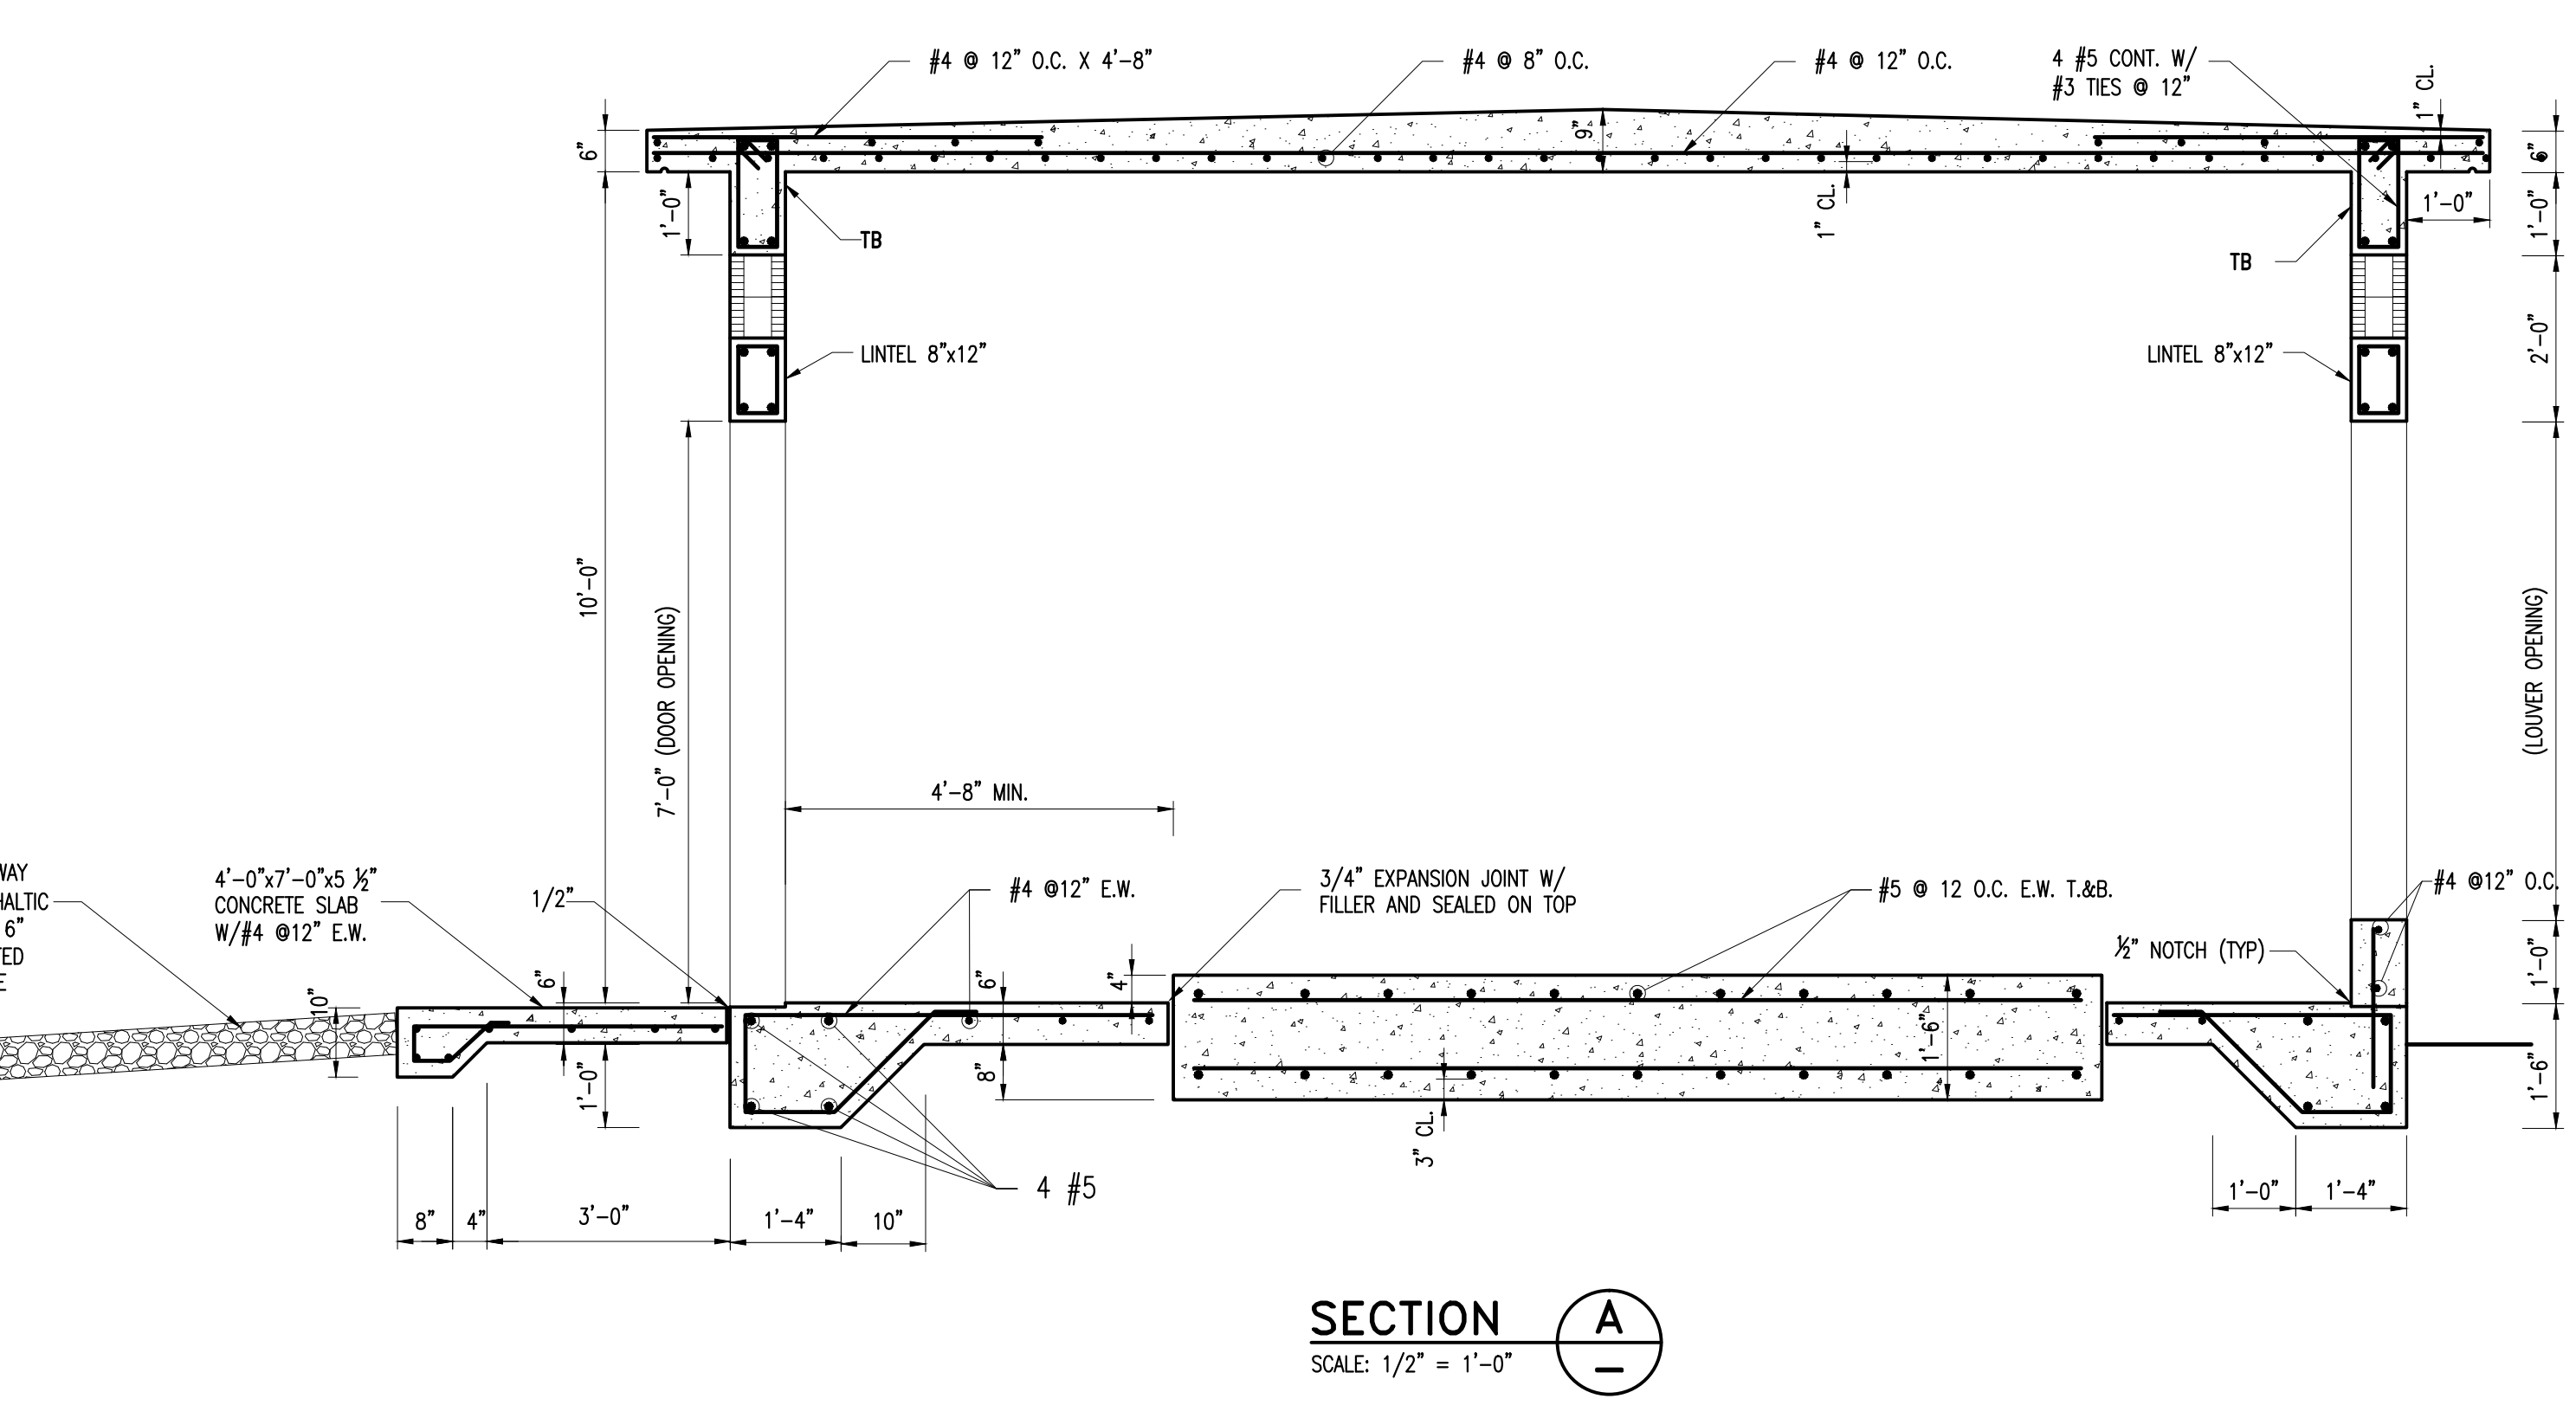

SLAB DETAILS FOR CONVAULT 250 GALLON TANK

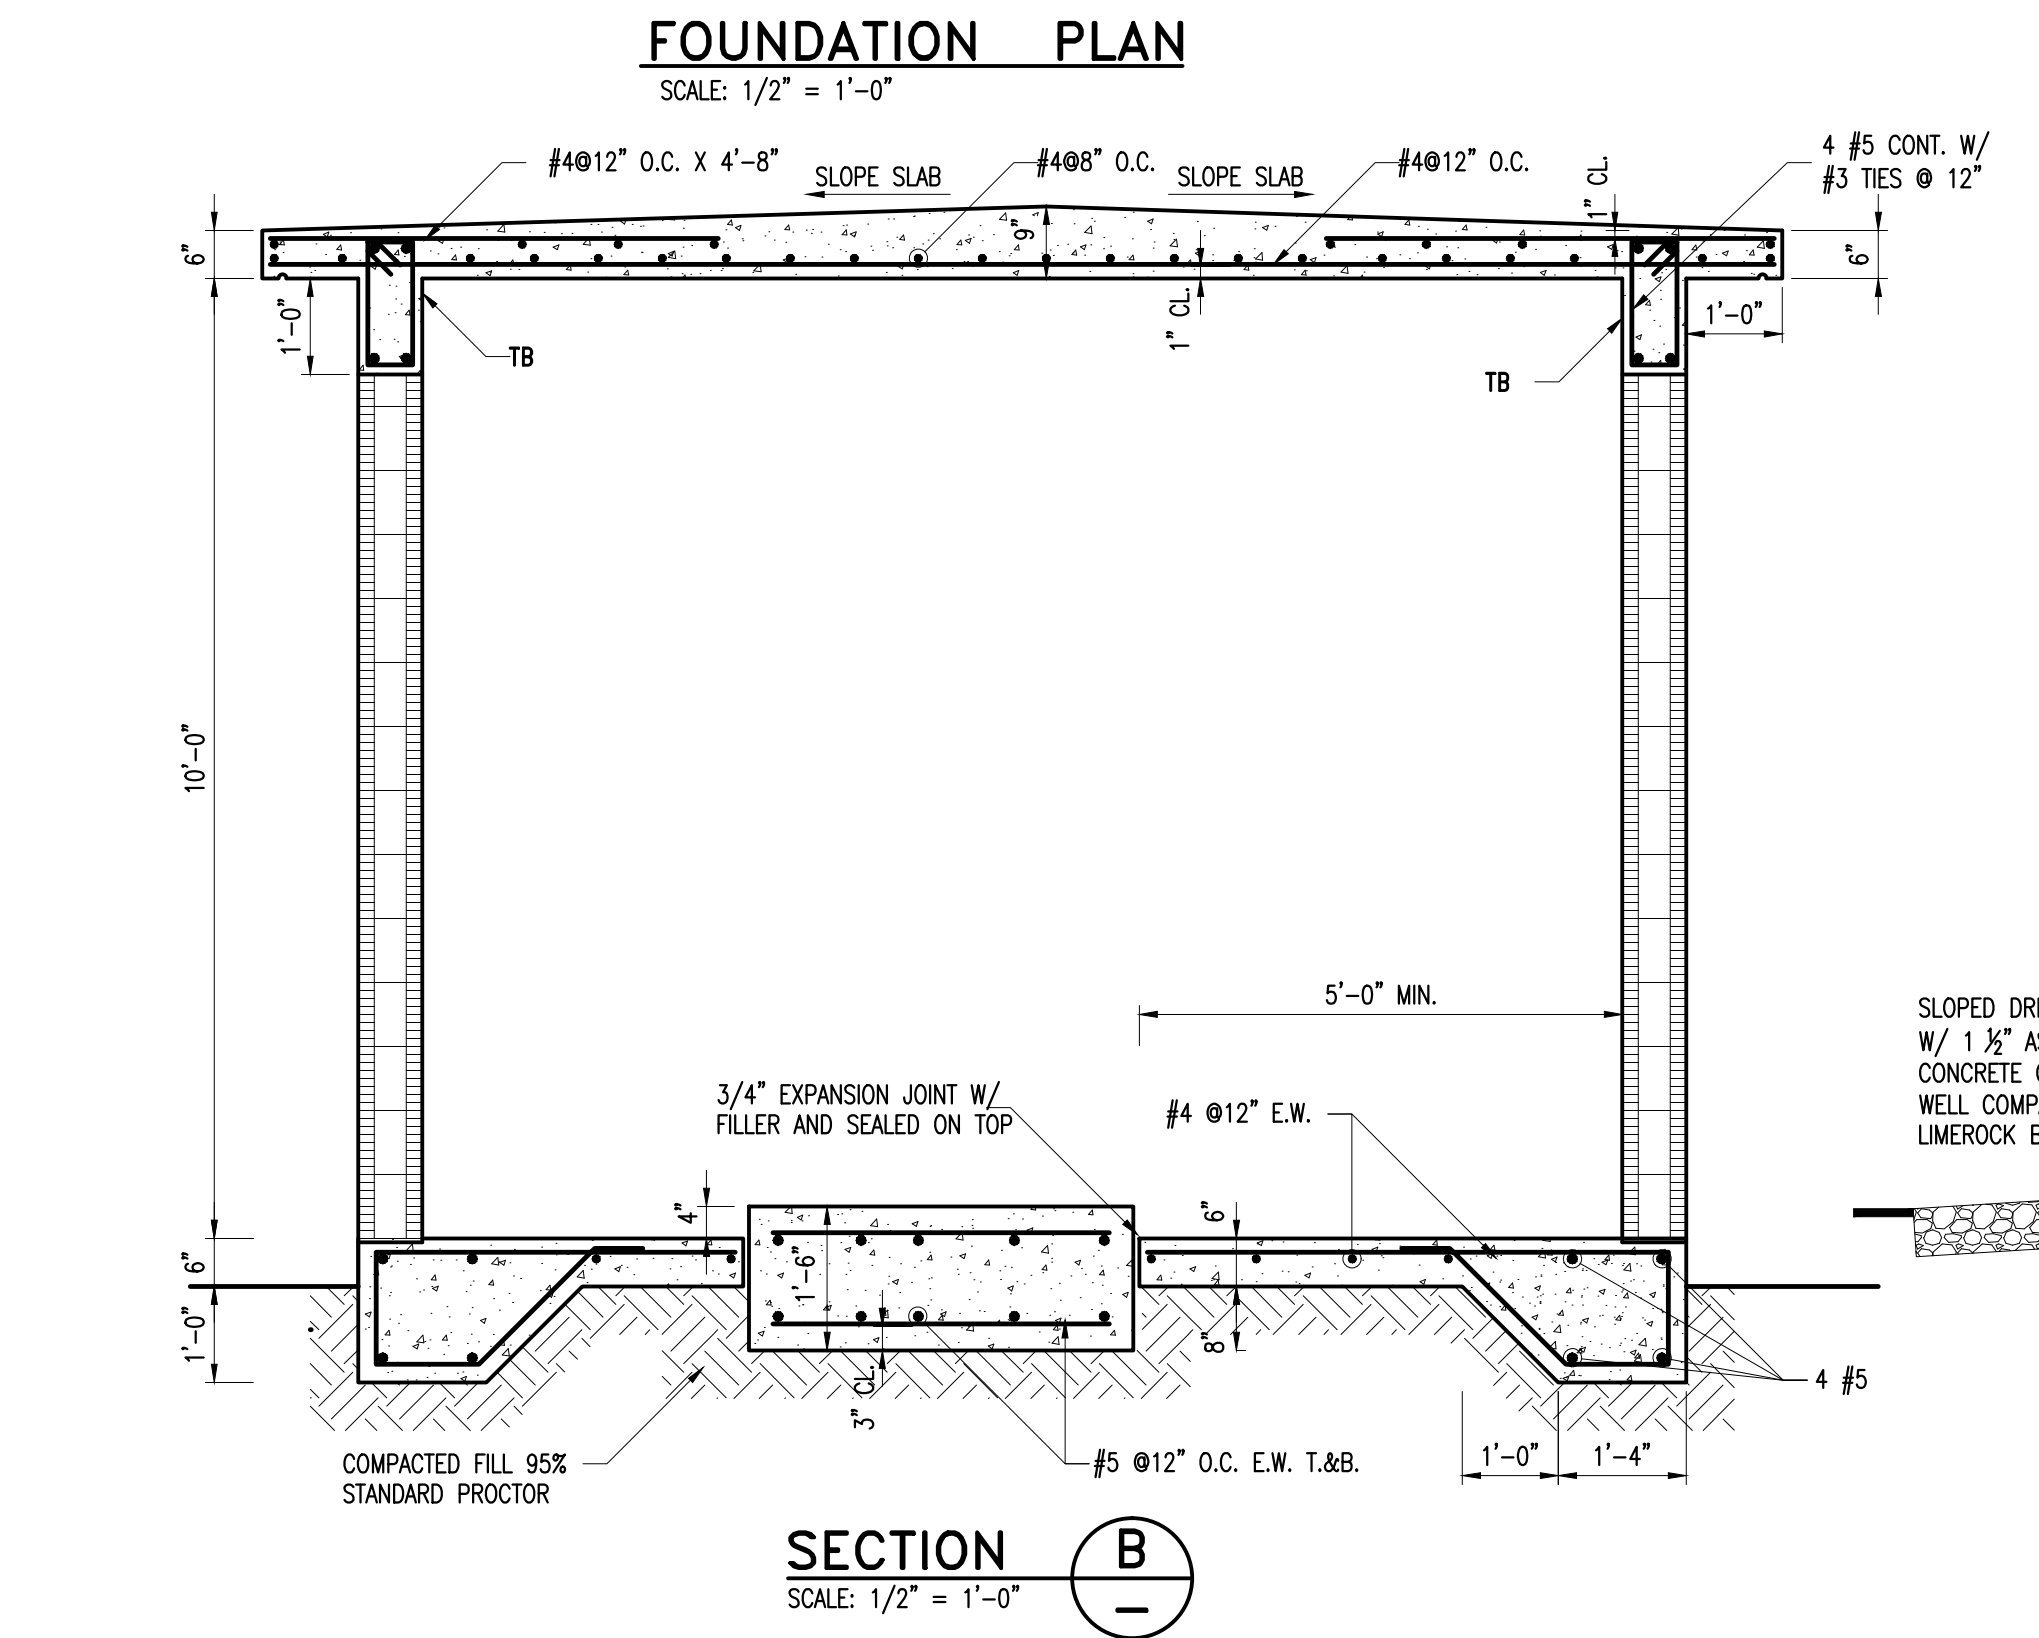

- NOTES:**
- THESE ARE NOT CONSTRUCTION DRAWINGS, BUT ARE GUIDELINES FOR MINIMUM DESIGN REQUIREMENTS. THE USER SHALL VERIFY AND MODIFY INFORMATION SHOWN HEREIN IN ACCORDANCE WITH ALL APPLICABLE CODES AND STANDARDS, TO COMPLY WITH THE REQUIREMENTS OF THEIR DESIGN AND MD-WASD REQUIREMENTS.
 - THE DIMENSIONS OF THE CONCRETE SLAB FOR THE GENERATOR SHALL BE VERIFY ACCORDING WITH THE GENERATOR CHARACTERISTICS FROM THE MANUFACTURER.
 - THE DIMENSIONS OF THE OPENINGS FOR THE FAN AND LOUVERS SHALL BE VERIFY ACCORDING WITH THE GENERATOR CHARACTERISTICS AND COMPLY WITH THE MD-WASD SPECIFICATIONS AND ALL APPLICABLE CODES.

DRAWING HISTORY

RELEASED FOR	DATE	BY
REVIEW 30%		
REVIEW 70%		
REVIEW 100%		
PERMIT		

REVISIONS

No.	DESCRIPTION	DATE	BY

APPROVALS

CHIEF ENGINEER:	
SECTION HEAD:	
PROJECT MGR.:	
DESIGNED: X.X.X.	CHECKED: X.X.X.
DRAWN: X.X.X.	FINAL CHECK: X.X.X.

XXXXXXXX XXXXX
XXXXXXXXXXXX Engineer
State of Florida License No. 00000
Date: _____
ER No. : S000000 PCTS No. : 00000
FILE NAME: 000000.DWG
DATE: AUG. 28, 2012 SCALE: AS NOTED
SHEET S-5
DWG. No. S-00000-A