

# MIAMI DADE WATER AND SEWER DEPARTMENT

3071 S.W. 38th AVENUE MIAMI, FL 33146-1520




## SUBMERSIBLE SEWAGE PUMPING STATION WITHOUT EMERGENCY GENERATOR

### PUMPING STATION No. 0000

PROJECT OFFICIAL ADDRESS MIAMI, FL 33000-0000

PCTS 00000

CONTRACT X-000 or RPQ/ ER X00000

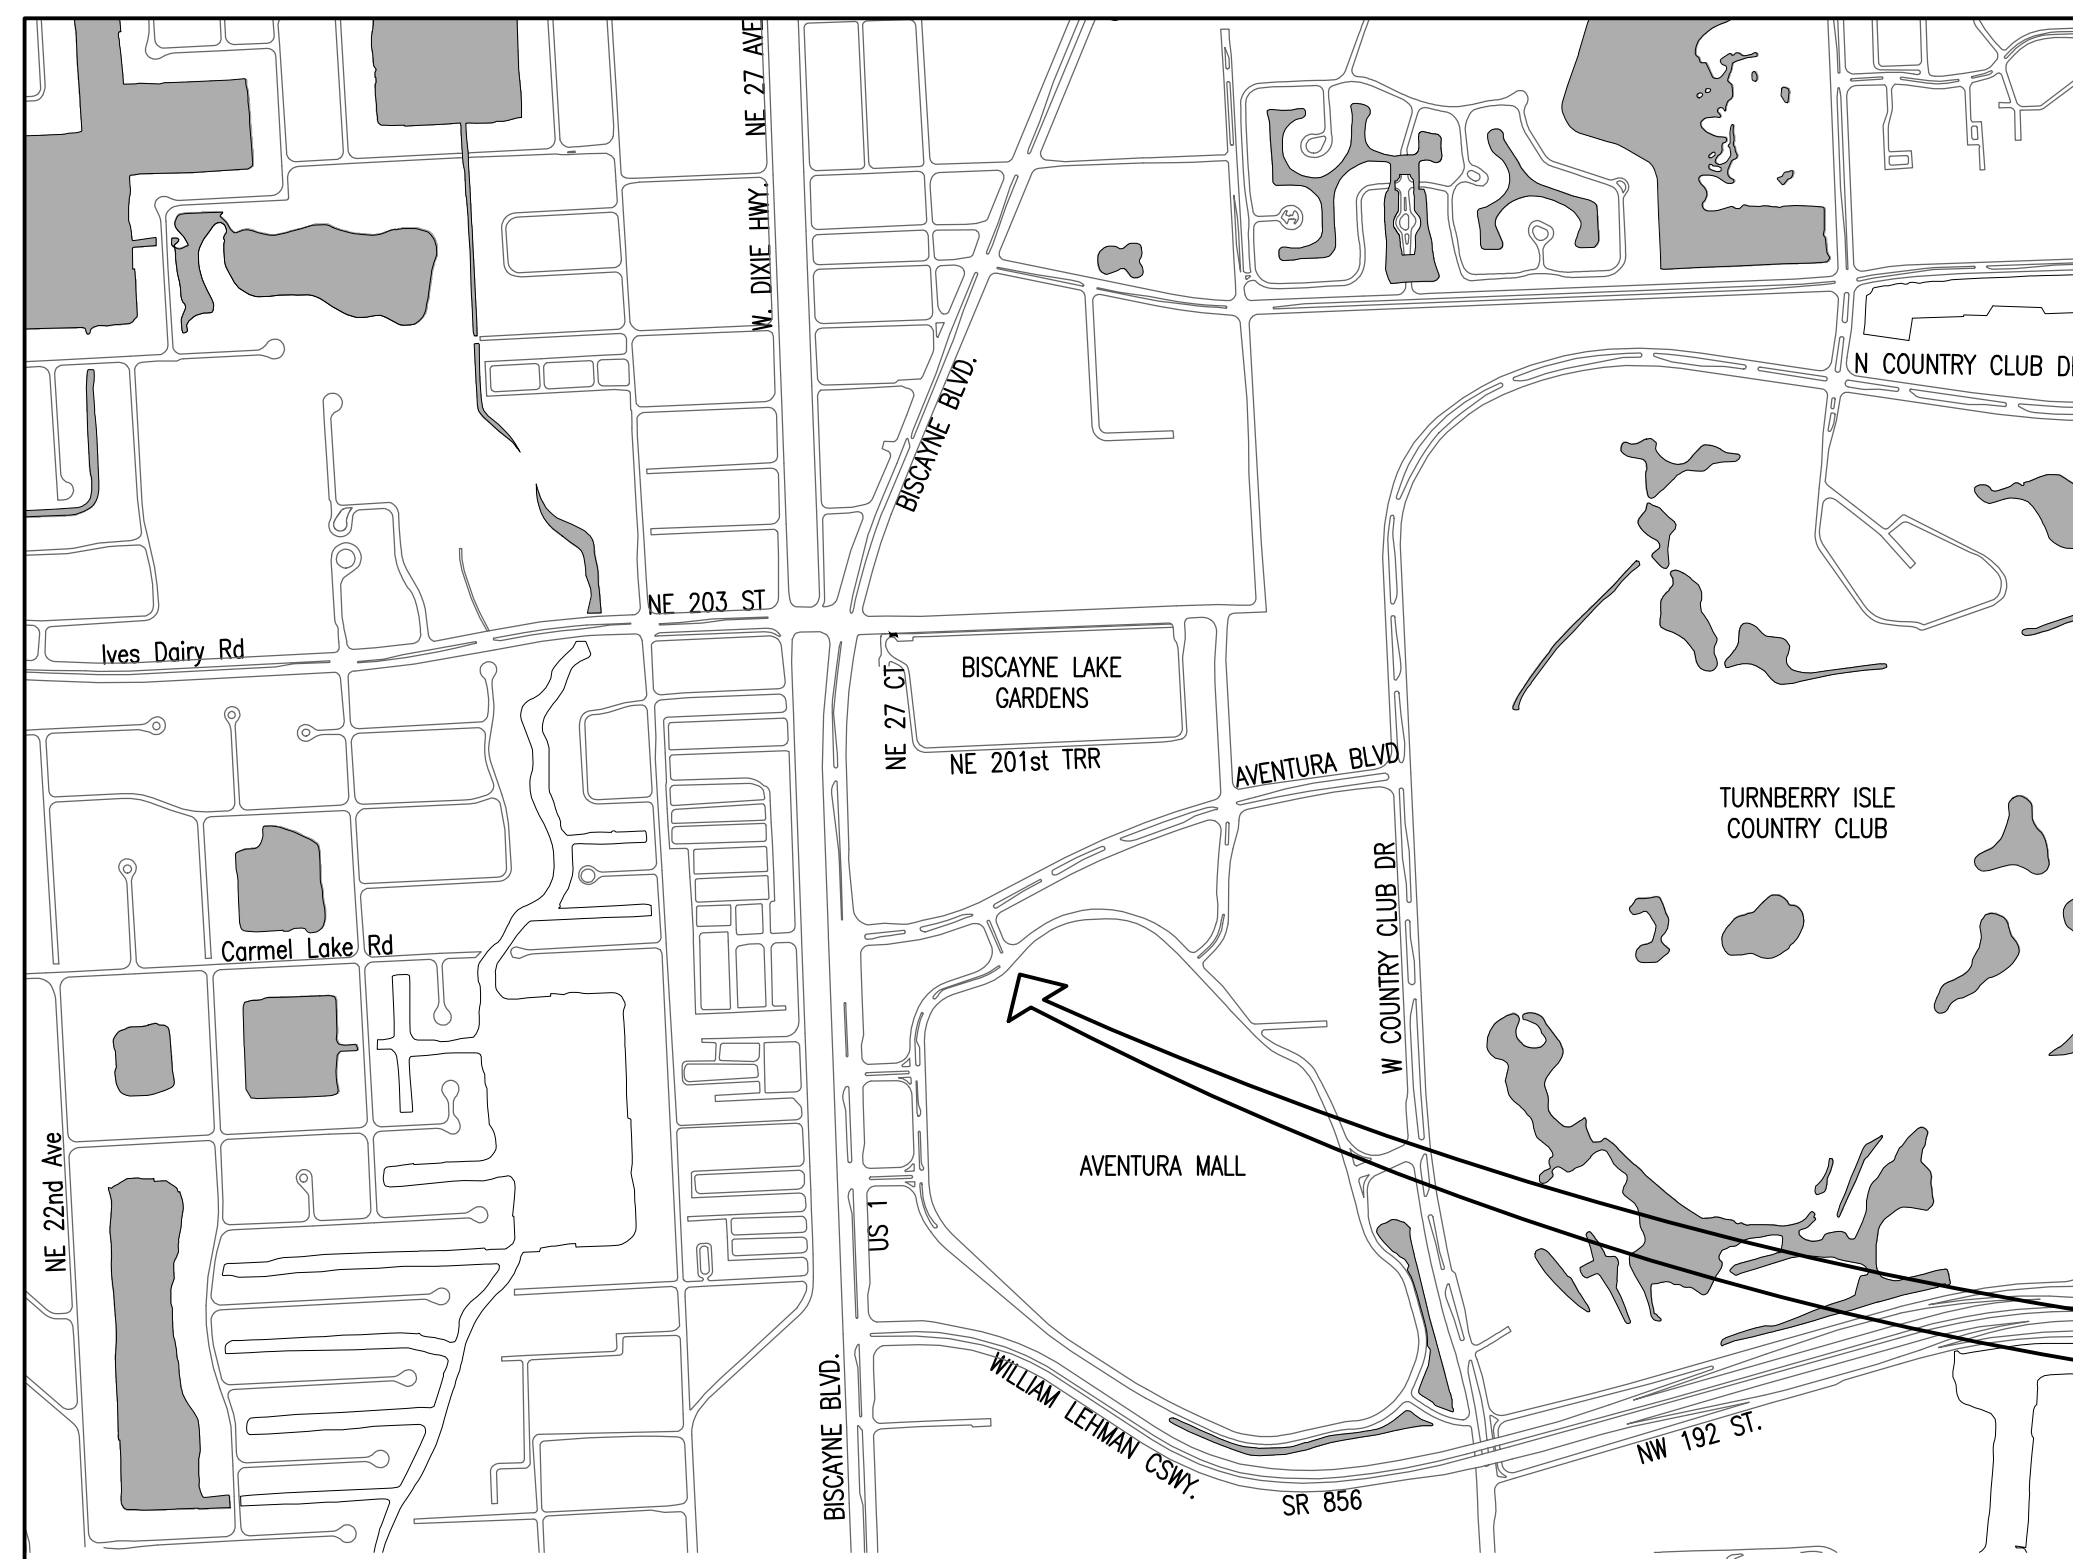

**LOCATION PLAN**

CITY NAME or MIAMI-DADE COUNTY  
T50-S40-R00  
FOLIO 00-0000-000-0000

**SHEET INDEX**

- C-1 COVER SHEET
- C-2 SITE PLAN, LEGEND AND NOTES
- M-1 MECHANICAL PLAN, SECTIONS, DETAILS AND PUMP DATA
- E-1 ELECTRICAL GENERAL NOTES
- E-2 ELECTRICAL SITE PLAN AND NOTES
- E-3 (SELECT ONE)
  - E-3A POWER/CONTROL (MPE) AND WIRING SCHEDULE
  - E-3B MULTISMART CONTROL AND SCADA TERMINALS
- E-4 ELECTRICAL CONTROL PANEL AND TYPICAL DETAILS
- E-5 R.T.U. INSTALLATION WIRING DIAGRAMS
- S-1 STRUCTURAL GENERAL NOTES
- S-2 WET WELL AND VAULT VALVE STRUCTURAL PLAN, SECTIONS AND DETAILS
- S-3 CONCRETE SLABS FOR EQUIPMENT
- S-4 CHAIN LINK FENCE AND GATES



Know what's below.  
Call before you dig.

S.S.O.C.O.F. TICKET No. XXXXXXXX  
DATE: XX/XX/2014  
FIELD BOOK XXXX, PAGES XXXXX

XXXX X. XXXXX, P.E.  
Engineer of Record  
State of Florida - License No.00000  
3575 S. Le Jeune Rd. Miami, FL 33146  
WASD (786) 268-0000  
Date: \_\_\_\_\_

XXXX X. XXXXX  
Project Manager  
ENGINEERING & DESIGN DIVISION  
3575 S. Le Jeune Rd. Miami FL 33146  
WASD (786) 268-0000  
Date: \_\_\_\_\_

APPROVALS	DRAWING HISTORY	DATE	BY	No.	REVISION	DATE	BY	FILE NAME: 00000X00.DWG
CHIEF ENGINEER: J.B.F.	X REVIEW 00%	04/21/15	LMS	1	XXXXXX XXXXXX	04/21/15	LMS	DATE: 04/21/15 DRAWN: L.M.S.
DESIGN MNGR.: R.J.A.								SHEET C-1 OF 000
SECTION HEAD: X.X.X.								DWG. No. X-00000-D